


ROOM FINISH SCHEDULE_LEVEL 1											
RM NO	ROOM NAME	FLOOR		WALL			CEILING		REMARKS		
		FLOOR	BASE	NORTH	EAST	SOUTH	WEST	MAT'L		FINISH	
FIRST FLOOR											
101	LOBBY	LVT1	VB2	P10	P10	P10	P10				
102	CONFERENCE	LVT1	VB2	P10	P10	P10	P10				
103	SRO OFFICE	LVT1	VB1	P10	P10	P10	P10				
104	TOILET	RSF1	RSB1	T1/P10	T1/P10	T1/P10	T1/P10				
105	RECEPTION	LVT1	VB2	P10	P10	P10	P10				
106	NURSES SUITE	LVT1	VB1	P10	P10	P10	P10				
107	RECORDS	LVT1	VB1	P10	P10	P10	P10				
108	CENTRAL OFFICE	LVT1	VB1	P10	P10	P10	P10				
109	ENROLLMENT	LVT1	VB1	P10	P10	P10	P10				
110	STAFF TOILET	RSF1	RSB1	T1/P10	T1/P10	T1/P10	T1/P10				
111	STAFF TOILET	RSF1	RSB1	T1/P10	T1/P10	T1/P10	T1/P10				
112	API OFFICE	LVT1	VB1	P10	P10	P10	P10				
113	BUSINESS/HR	LVT1	VB1	P10	P10	P10	P10				
114	OPERATIONS	LVT1	VB1	P10	P10	P10	P10				
115	LOUNGE	LVT1	VB2	P10	P10	P10	P10				
116	DEAN OFFICE	LVT1	VB1	P10	P10	P10	P10				
117	ESE STAFFING	LVT1	VB1	P10	P10	P10	P10				
118	SUPPORT OFFICE	LVT1	VB1	P10	P10	P10	P10				
119	ACADEMICS	LVT1	VB1	P10	P10	P10	P10				
120	PRINCIPAL	LVT1	VB1	P10	P10	P10	P10				
121	6TH-8TH GRADE CLASSROOM	LVT1	VB1	P10	P10	P10	P10				
122	6TH-8TH GRADE CLASSROOM	LVT1	VB1	P10	P10	P10	P10				
123	6TH-8TH GRADE CLASSROOM	LVT1	VB1	P10	P10	P10	P10				
124	RISER ROOM	SC	VB1	P10	P10	P10	P10				
125	FACILITIES TECH STORAGE	LVT1	VB1	P10	P10	P10	P10				
126	6TH-8TH GRADE CLASSROOM	LVT1	VB1	P10	P10	P10	P10				
127	SCIENCE/COMPUTER CLASSROOM	LVT1	VB1	P10	P10	P10	P10				
128	SCIENCE/COMPUTER CLASSROOM	LVT1	VB1	P10	P10	P10	P10				
129	SPECIALTY EARTH SCIENCE CLASSROOM	LVT1	VB1	P10	P10	P10	P10				
130	WASHROOM	RSF1	RSB1	T1/P10	T1/P10	T1/P10	T1/P10				
131	GIRLS RR	RSF1	RSB1	T1/P10	T1/P10	T1/P10	T1/P10				
132	BOYS RR	RSF1	RSB1	T1/P10	T1/P10	T1/P10	T1/P10				
133	JANITORS	RSF1	RSB1	FRP1	FRP1	FRP1	FRP1				
	LVT1: TBD 12" x 12" SF							P10			
	LVT2: TBD 12" x 12" SF							P10			
	LVT3: TBD 12" x 12" SF							P10			
	LVT4: TBD 12" x 12" SF							P10			
	RF-1: 6'0" SY							P10			
	RSF-1: Altro: Aquarius: TBD Color: 6'7" x 65'5" 6'7" SY							P10			
	SV Items SF							P10			
	SV: CC 0" LF							T1/P10			
	SV: CS 0" LF							FRP1			
	SV: IC EA							P10			
	SV: OC EA							P10			
	SV WR 0" LF							P10			
	VB1: TBD 4" LF							P10			
	VB2: Flexco: Resolute: TBD Color: 6" 6" LF							P10			
	T-1: TBD 3" x 6" SF							P10			
	TS: Schluter: Quadec / Satin Anodized - Wainscot Cap 0" LF							T1/P10			
	TS: Schluter: TBD: Satin Anodized - Outside Corners 0" LF							FRP1			
	TS: LVT / Sheet Vinyl 0" LF							FRP1			
	Grout: TBD SF							FRP1			
	Project Size SF							T1/P10			

ROOM FINISH SCHEDULE_LEVEL 1											
RM NO	ROOM NAME	FLOOR		WALL				CEILING		REMARKS	
		FLOOR	BASE	NORTH	EAST	SOUTH	WEST	MAT'L	FINISH		
160	TOILET	RSF1	RSB1	T1/P10	T1/P10	T1/P10	T1/P10				
161	CAFETERIA	LVT1	VB2	P10/P11	P10/P11	P10/P11	P10/P11				
162	GYMNASIUM	RF	VB1	SEE ELEV.	SEE ELEV.	SEE ELEV.	SEE ELEV.				
163	GYM STORAGE	LVT1	VB1	P10	P10	P10	P10				
164	BOYS LOCKER RM.	RSF1	RSB1	P10	P10	P10	P10				
165	BOYS RR	RSF1	RSB1	T1/P10	T1/P10	T1/P10	T1/P10				
166	GIRLS RR	RSF1	RSB1	T1/P10	T1/P10	T1/P10	T1/P10				
167	GIRLS LOCKER RM.	RSF1	RSB1	P10	P10	P10	P10				
C102	CORRIDOR	LVT1	VB2	P10/P11	P10/P11	P10/P11	P10/P11				
C103	CORRIDOR	LVT1	VB2	P10/P11	P10/P11	P10/P11	P10/P11				
C106	CORRIDOR	LVT1	VB2	P10/P11	P10/P11	P10/P11	P10/P11				
C106	HALL	LVT1	VB2	P10/P11	P10/P11	P10/P11	P10/P11				
CA101	CORRIDOR	LVT1	VB2	P10/P11	P10/P11	P10/P11	P10/P11				
CA104	CORRIDOR	LVT1	VB2	P10/P11	P10/P11	P10/P11	P10/P11				
EL1.1	ELEV.	LVT1	VB2	P10	P10	P10	P10				
STA.1	STAIR A	LVT1	VB2	P10	P10	P10	P10				
STB.1	STAIR B	LVT1	VB2	P10	P10	P10	P10				
STC.1	STAIR C	LVT1	VB2	P10	P10	P10	P10				

INTERIOR FINISH SCHEDULE				
MARK	MANUFACTURER	MODEL	COMMENTS	
ACOUSTICAL WALL PANEL				
AP2				
AP4	SHERWIN WILLIAMS	#SW7066 "GRAY MATTERS"; SHEEN: REFER TO SPECIFICATIONS		
AP5	SHERWIN WILLIAMS	#SW9177 "SALTYDOG"; SHEEN: REFER TO SPECIFICATIONS		
AP6	SHERWIN WILLIAMS	#SW7074 "SOFTWARE"; SHEEN: REFER TO SPECIFICATIONS		
BASES, BUMPERS, AND FRP				
VB1	TBD	4" VINYL BASE, COLOR: ***		
VB2	FLEXCO	MODEL: RESOLUTE 6" VINYL BASE, COLOR: ***		
CEILING				
ACT1	REFER TO SPECIFICATIONS	REFER TO SPECIFICATIONS, 24x24		
ACT3	REFER TO SPECIFICATIONS	REFER TO SPECIFICATIONS, 24x24, VINYL FACE		
ACT4	REFER TO SPECIFICATIONS	REFER TO SPECIFICATIONS, 24x24, WITH INSULATION ABOVE ACT PANELS	INSULATION TO EXTEND OVER PERIMETER WALLS AND A MIN. OF 2" INTO ADJACENT CEILING SPACE	
EPOXY COUNTERTOP				
EC-1			COLOR: TBD	
FLOORING				
CP11	TBD	24"x24" CARPET TILE, COLLECTION: ***; STYLE: ***; COLOR: ***; INSTALLATION: ***		
RSB1	TBD	RESILIENT SHEET FLOORING BASE TO MATCH FLOORING, COLLECTION: ***; STYLE: ***; COLOR: ***		
RSF1	TBD	RESILIENT SHEET FLOORING, COLLECTION: ***; STYLE: ***; COLOR: ***		
MISCELLANEOUS				
M4	SCHLUTER	SCHLUTER TRIM PROFILE: SATIN ANODIZED FINISH	REFER TO KEYNOTE FOR TRIM PROFILE	
PL-1				
PAINT				
P7	SHERWIN WILLIAMS	#SW6182 "ETHEREAL WHITE"; SHEEN: REFER TO SPECIFICATIONS		
P8	SHERWIN WILLIAMS	#SW7066 "GRAY MATTERS"; SHEEN: REFER TO SPECIFICATIONS		
P9	SHERWIN WILLIAMS	#SW9177 "SALTYDOG"; SHEEN: REFER TO SPECIFICATIONS		
P10	SHERWIN WILLIAMS	#OC-71 "SAND DOLLAR"; SHEEN: REFER TO SPECIFICATIONS		
P11	SHERWIN WILLIAMS	#SW7011 "NATURAL CHOICE"; SHEEN: REFER TO SPECIFICATIONS		
P12	SHERWIN WILLIAMS	#SW6795 "MAJOR BLUE"; SHEEN: REFER TO SPECIFICATIONS		
PLASTIC LAMINATE				
PL-1				
PL-2				
TRIM				
WD1				

- ### GENERAL NOTES
- A. REFER TO SHEET G001, CODE REVIEW, FOR REQUIRED FLAME SPREAD AND SMOKE DEVELOPMENT RATINGS OF ALL FINISHES. REFER TO FINISH SCHEDULE AND FINISH SPECIFICATIONS FOR ADDITIONAL INFORMATION.
- B. FLOOR FINISH PATTERNS ON PLAN ARE FOR GENERAL CONFIGURATION, INDICATING DIRECTION ONLY, U.N.O., UNLESS SPECIFICALLY INDICATED OTHERWISE ON PLAN. FLOORING SHALL BE INSTALLED CENTERED WITHIN THE ROOM OR SPACE WITH LONG DIRECTION OF THE FLOORING PLANK OR TILE RUNNING THE LONG DIRECTION OF THE ROOM OR SPACE.
- C. FULL FLOORING PLANKS, TILES, OR SHEETS SHALL BE USED IN FLOORING INSTALLATION WHEREVER POSSIBLE.
- D. ALL FLOOR FINISHES SHALL BE INSTALLED WITH TOP EDGES LEVEL W/ ADJACENT MATERIAL TOP EDGES; CONFIRM TILE THICKNESS AS THICKNESS MAY VARY; CONFIRM THAT NO OVERALL FLOATING OF FLOOR IS REQUIRED.
- E. REFER TO PLUMBING DRAWINGS FOR DIMENSIONS & LOCATIONS OF FLOOR DRAINS & FLOOR SINKS.
- F. REFER TO PARTITION TYPE DETAILS AND INTERIOR ELEVATIONS FOR HEIGHT OF WALL FINISHES.
- G. REFER TO INTERIOR ELEVATIONS FOR ADDITIONAL PAINT COLOR INFORMATION AND LOCATIONS.
- H. ALL FINISHES AND PAINT COLORS SHALL TERMINATE AT AN INSIDE CORNER WHEREVER POSSIBLE, U.N.O.; GC SHALL REQUEST CLARIFICATION FROM ARCHITECT IF PRESCRIBED MATERIAL TERMINATION IS AMBIGUOUS OR INFEASIBLE.
- I. WALL TILE SHALL BE INSTALLED IN RESTROOMS TO A HEIGHT OF 5'-0" AFF, U.N.O., ON ALL PLUMBING WALLS, BEHIND PLUMBING FIXTURES - INCLUDING DRINKING FOUNTAINS - ON WALLS ADJACENT TO PLUMBING FIXTURES, AND BEHIND HAND DRYERS.
- J. ALL HOLLOW METAL DOOR FRAMES SHALL BE PAINTED.
- K. FRP IN KITCHENS SHALL BE FULL HEIGHT; FRP IN ALL OTHER APPLICATIONS SHALL BE TO 5'-0" U.N.O.
- L. WHERE APPLICABLE, PATCH & REPAIR FLOORING IN ALL SCOPE OF WORK AREAS TO MATCH EXISTING UNLESS NEW FINISH NOTED IN ROOM FINISH SCHEDULE.
- M. UPON COMPLETION OF THE WORK, THE G.C. SHALL PROVIDE AND LEAVE ON SITE (2) BOX EACH OF ALL WALL TILE, FLOOR TILE, CARPET TILE, AND CEILING TILE USED.
- ### FLOORING TRANSITION NOTES
- A. ALL FLOORING TRANSITIONS SHALL COMPLY WITH ICC/ANSI A117.1, REFER TO ACCESSIBILITY GUIDELINES.
- B. COORDINATE FLOORING TRANSITIONS & BASE TILE INSTALLATION W/ MILLWORK SHOP DRAWINGS & FIELD CONDITIONS.
- C. TRANSITIONS BETWEEN ROOMS SHALL BE CENTERED ON DOOR FRAME.
- LVT to SC SCHLUTER VINPRO-U; COLOR TBD.
- LVT to LVT SCHLUTER VINPRO-T; COLOR TBD.
- LVT to CPT SCHLUTER VINPRO-S; COLOR TBD.
- LVT to TILE SCHLUTER RENO-U; COLOR TBD.
- ### DRAWING NOTES

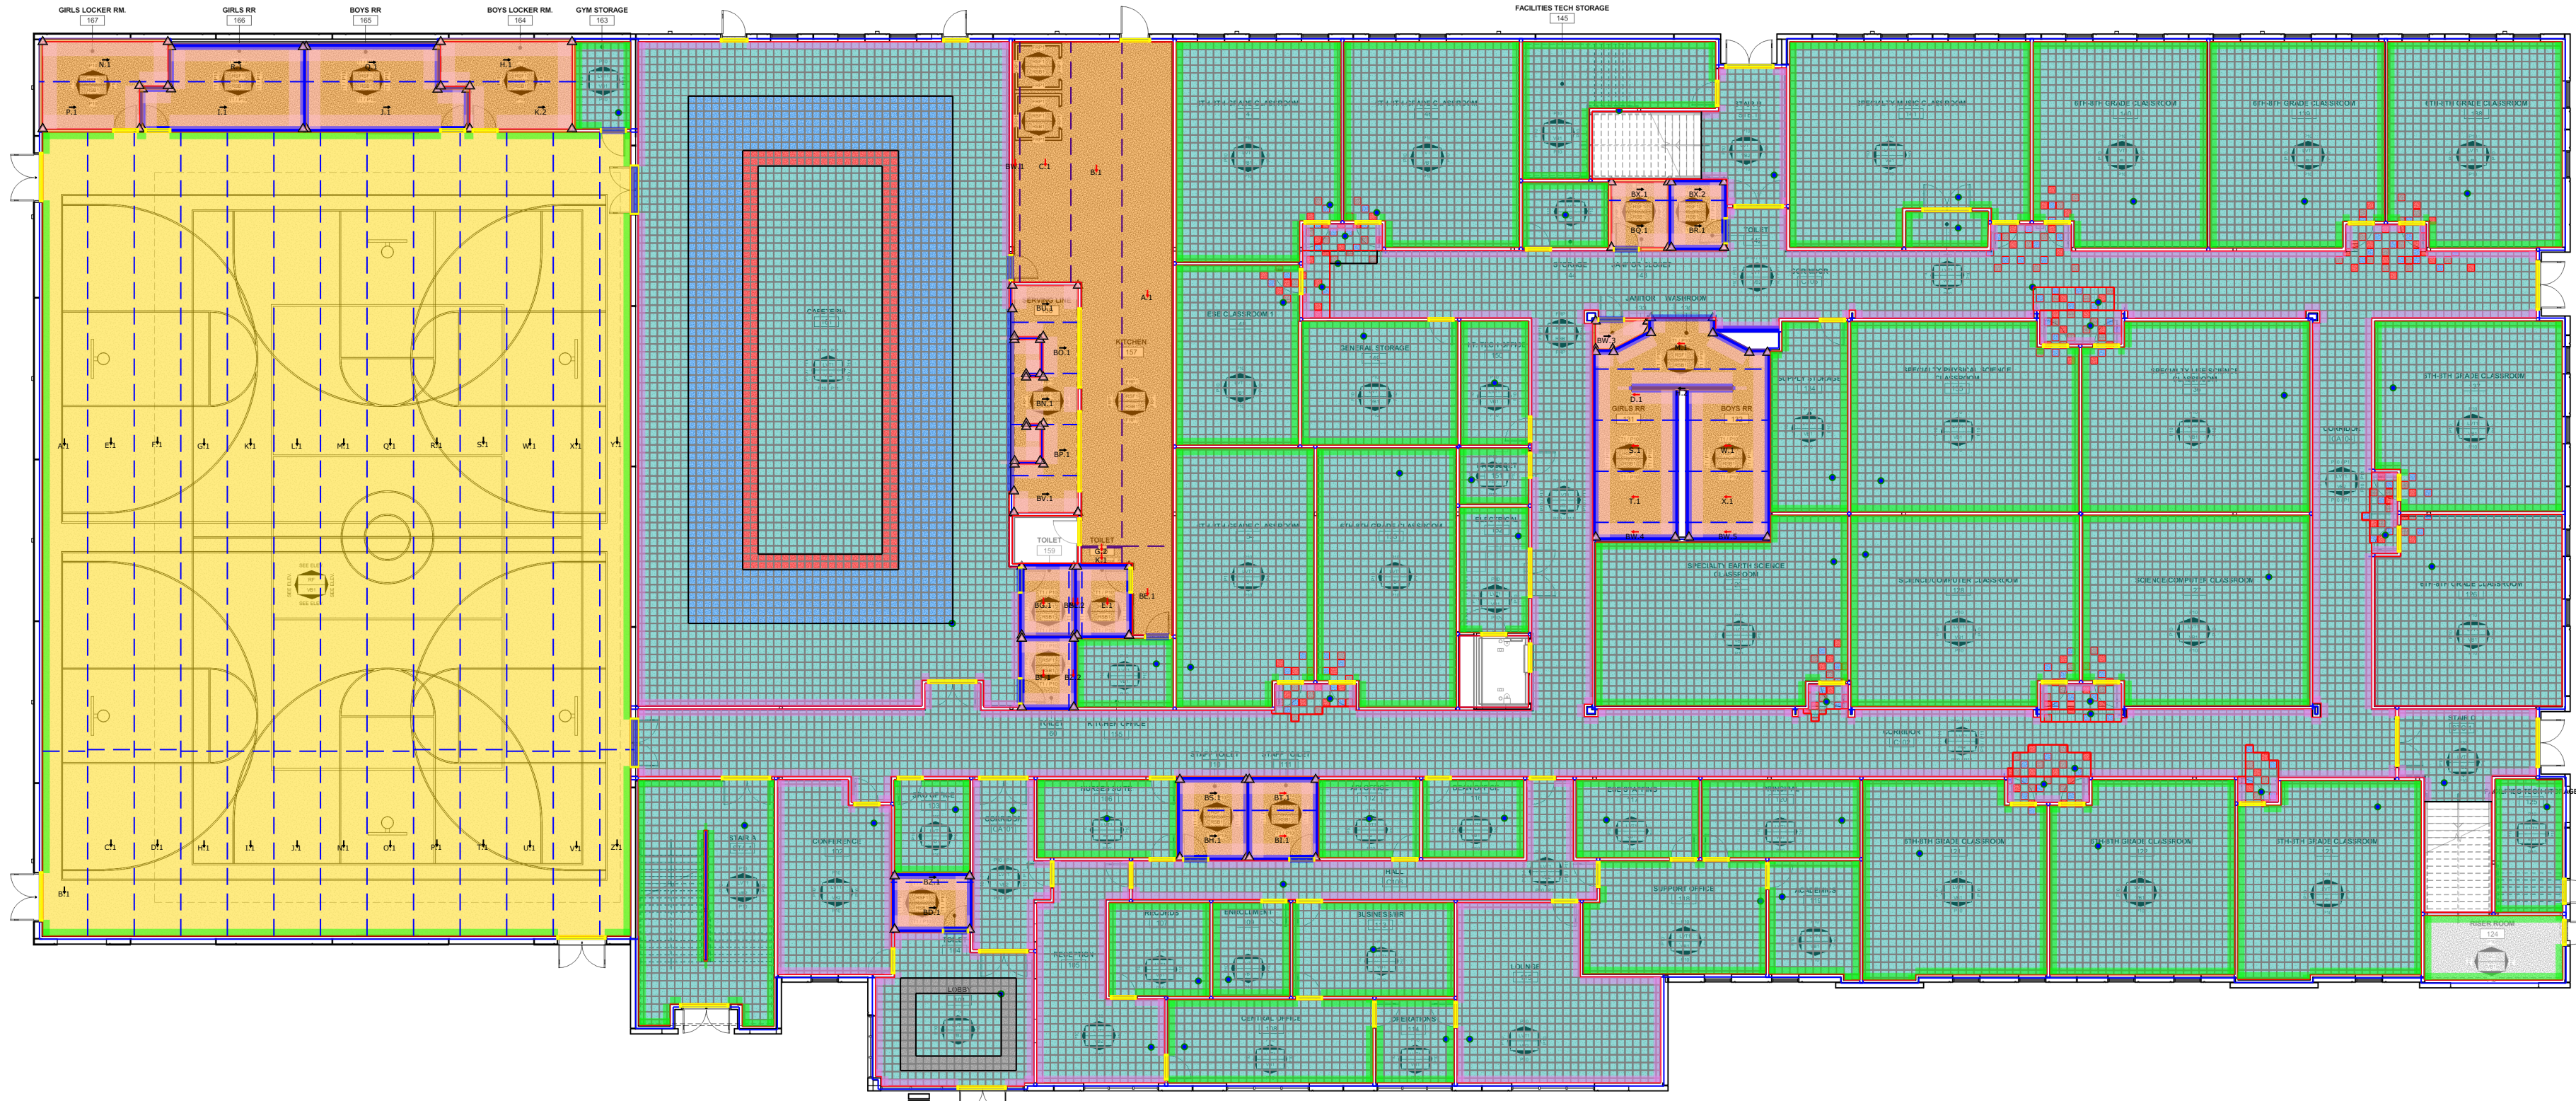

A1 FIRST FLOOR FINISH PLAN
A1101 1" = 10'-0"

MUSSMAN ARCHITECTS

610 N. MAIN STREET | GREENVILLE, SC 29601
864.626.6303
musmanarchitect.com

STATE OF FLORIDA
JACOB W. MUSSMAN
ARCHITECT
REGISTERED ARCHITECT
A839980

SEAL DATE: 07.20.2020

SUMMIT

SEMINOLE SCIENCE ACADEMY
3580 N. 17TH ST
LAKE MARY, FL 32746

SEMINOLE SCIENCE ACADEMY
11.05.2024
11.05.2024
0
0

DATE
11.05.2024
11.05.2024
0
0

DESCRIPTION
REVISED SET
ISSUE FOR PERMIT

PROJECT NUMBER: 024007

FINISH PLAN

A1101
SHEET NO.

ROOM FINISH SCHEDULE_LEVEL 2										
RM NO	ROOM NAME	FLOOR		WALL			CEILING		REMARKS	
		FLOOR	BASE	NORTH	EAST	SOUTH	WEST	MAT'L		FINISH
SECOND FLOOR										
201	CONFERENCE 2	LVT1	VB2	P10	P10	P10	P10			
202	SPECIALTY ART CLASSROOM	LVT1	VB1	P10	P10	P10	P10			
203	SPECIALTY CHEMISTRY CLASSROOM	LVT1	VB1	P10	P10	P10	P10			
204	BIOLOGY LAB	LVT1	VB1	P10	P10	P10	P10			
205	STORAGE	LVT1	VB1	P10	P10	P10	P10			
206	SPECIALTY PLTW CLASSROOM	LVT1	VB1	P10	P10	P10	P10			
207	9TH-12TH GRADE CLASSROOM	LVT1	VB1	P10	P10	P10	P10			
208	9TH-12TH GRADE CLASSROOM	LVT1	VB1	P10	P10	P10	P10			
209	9TH-12TH GRADE CLASSROOM	LVT1	VB1	P10	P10	P10	P10			
210	9TH-12TH GRADE CLASSROOM	LVT1	VB1	P10	P10	P10	P10			
211	BDA CLOSET	LVT1	VB1	P10	P10	P10	P10			
212	9TH-12TH GRADE CLASSROOM	LVT1	VB1	P10	P10	P10	P10			
213	SPECIALTY BIOLOGY CLASSROOM	LVT1	VB1	P10	P10	P10	P10			
214	SCIENCE/COMPUTER CLASSROOM	LVT1	VB1	P10	P10	P10	P10			
215	TOILET	RSF1	RSB1	T1/P10	T1/P10	T1/P10	T1/P10			
216	BOYS RR	RSF1	RSB1	T1/P10	T1/P10	T1/P10	T1/P10			
217	GIRLS RR	RSF1	RSB1	T1/P10	T1/P10	T1/P10	T1/P10			
218	COMPUTER LAB	LVT1	VB1	P10	P10	P10	P10			
219	COMPUTER LAB	LVT1	VB1	P10	P10	P10	P10			
220	TESTING STORAGE	LVT1	VB1	P10	P10	P10	P10			
221	FACILITIES OFFICE	LVT1	VB1	P10	P10	P10	P10			
222	9TH-12TH GRADE CLASSROOM	LVT1	VB1	P10	P10	P10	P10			
223	TESTING COORDINATOR OFFICE	LVT1	VB1	P10	P10	P10	P10			
224	COUNSELOR OFFICE	LVT1	VB1	P10	P10	P10	P10			
225	9TH-12TH GRADE CLASSROOM	LVT1	VB1	P10	P10	P10	P10			
226	DEAN OFFICE 2	LVT1	VB1	P10	P10	P10	P10			
227	ROBOTICS LAB	LVT1	VB1	P10	P10	P10	P10			
228	STORAGE	LVT1	VB1	P10	P10	P10	P10			
229	API OFFICE 2	LVT1	VB1	P10	P10	P10	P10			
230	9TH-12TH GRADE CLASSROOM	LVT1	VB1	P10	P10	P10	P10			
231	COMPUTER LAB	LVT1	VB1	P10	P10	P10	P10			
232	COMPUTER LAB	LVT1	VB1	P10	P10	P10	P10			
233	9TH-12TH GRADE CLASSROOM	LVT1	VB1	P10	P10	P10	P10			
234	9TH-12TH GRADE CLASSROOM	LVT1	VB1	P10	P10	P10	P10			
235	SUPPLY STORAGE	LVT1	VB1	P10	P10	P10	P10			
236	I.T. CLOSET	LVT1	VB1	P10	P10	P10	P10			
237	ELECTRICAL	LVT1	VB1	P10	P10	P10	P10			
238	JANITOR	RSF1	RSB1	FRP1	FRP1	FRP1	FRP1			
239	GIRLS RR	RSF1	RSB1	T1/P10	T1/P10	T1/P10	T1/P10			
240	BOYS RR	RSF1	RSB1	T1/P10	T1/P10	T1/P10	T1/P10			
241	CURRICULUM STORAGE	LVT1	VB1	P10	P10	P10	P10			
242	TOILET	RSF1	RSB1	T1/P10	T1/P10	T1/P10	T1/P10			
243	TOILET	RSF1	RSB1	T1/P10	T1/P10	T1/P10	T1/P10			
244	STAFF LOUNGE 2	LVT1	VB1	P10	P10	P10	P10			
245	SCIENCE/COMPUTER CLASSROOM	LVT1	VB1	P10	P10	P10	P10			
246	9TH-12TH GRADE CLASSROOM	LVT1	VB1	P10	P10	P10	P10			
247	9TH-12TH GRADE CLASSROOM	LVT1	VB1	P10	P10	P10	P10			
248	SPECIALTY BIOLOGY CLASSROOM	LVT1	VB1	P10	P10	P10	P10			
249	9TH-12TH GRADE CLASSROOM	LVT1	VB1	P10	P10	P10	P10			
250	9TH-12TH GRADE CLASSROOM	LVT1	VB1	P10	P10	P10	P10			
251	COUNSELOR OFFICE	LVT1	VB1	P10	P10	P10	P10			
252	9TH-12TH GRADE CLASSROOM	LVT1	VB1	P10	P10	P10	P10			
257	WASHROOM	RSF1	RSB1	T1/P10	T1/P10	T1/P10	T1/P10			
260	WASHROOM	RSF1	RSB1	T1/P10	T1/P10	T1/P10	T1/P10			


ROOM FINISH SCHEDULE_LEVEL 2										
RM NO	ROOM NAME	FLOOR		WALL				CEILING		REMARKS
		FLOOR	BASE	NORTH	EAST	SOUTH	WEST	MAT'L	FINISH	
262	CORRIDOR	LVT1	VB2	P10/P11	P10/P11	P10/P11	P10/P11			
263	CORRIDOR	LVT1	VB2	P10/P11	P10/P11	P10/P11	P10/P11			
CA201	CORRIDOR	LVT1	VB2	P10/P11	P10/P11	P10/P11	P10/P11			
CA202	CORRIDOR	LVT1	VB2	P10/P11	P10/P11	P10/P11	P10/P11			
CA203	CORRIDOR	LVT1	VB2	P10/P11	P10/P11	P10/P11	P10/P11			
EL1.2	ELEV.									
STA.2	STAIR A	LVT1	VB2	P10	P10	P10	P10			
STB.2	STAIR B	LVT1	VB2	P10	P10	P10	P10			
STC.2	STAIR C	LVT1	VB2	P10	P10	P10	P10			

INTERIOR FINISH SCHEDULE				
MARK	MANUFACTURER	MODEL		COMMENTS
ACOUSTICAL WALL PANEL				
AP2				
AP4	SHERWIN WILLIAMS	#SW7066 "GRAY MATTERS"; SHEEN: REFER TO SPECIFICATIONS		
AP5	SHERWIN WILLIAMS	#SW9177 "SALTYDOG"; SHEEN: REFER TO SPECIFICATIONS		
AP6	SHERWIN WILLIAMS	#SW7074 "SOFTWARE"; SHEEN: REFER TO SPECIFICATIONS		
BASES, BUMPERS, AND FRP				
VB1	TBD	4" VINYL BASE, COLOR: ***		
VB2	FLEXCO	MODEL: RESOLUTE 6" VINYL BASE, COLOR: ***		
CEILING				
ACT1	REFER TO SPECIFICATIONS	REFER TO SPECIFICATIONS, 24x24		
ACT3	REFER TO SPECIFICATIONS	REFER TO SPECIFICATIONS, 24x24, VINYL FACE		
ACT4	REFER TO SPECIFICATIONS	REFER TO SPECIFICATIONS, 24x24, WITH INSULATION ABOVE ACT PANELS		INSULATION TO EXTEND OVER PERIMETER WALLS AND A MIN. OF 2' INTO ADJACENT CEILING SPACE
EPOXY COUNTERTOP				
EC-1				COLOR: TBD
FLOORING				
CPT1	TBD	24"x24" CARPET TILE; COLLECTION: ***; STYLE: ***; COLOR: ***; INSTALLATION: ***		
RSB1	TBD	RESILIENT SHEET FLOORING BASE TO MATCH FLOORING; COLLECTION: ***; STYLE: ***; COLOR: ***		
RSF1	TBD	RESILIENT SHEET FLOORING; COLLECTION: ***; STYLE: ***; COLOR: ***		
MISCELLANEOUS				
M4	SCHLUTER	SCHLUTER TRIM PROFILE; SATIN ANODIZED FINISH		REFER TO KEYNOTE FOR TRIM PROFILE
PL-1				
PAINT				
P7	SHERWIN WILLIAMS	#SW6182 "ETHEREAL WHITE"; SHEEN: REFER TO SPECIFICATIONS		
P8	SHERWIN WILLIAMS	#SW7066 "GRAY MATTERS"; SHEEN: REFER TO SPECIFICATIONS		
P9	SHERWIN WILLIAMS	#SW9177 "SALTYDOG"; SHEEN: REFER TO SPECIFICATIONS		
P10	SHERWIN WILLIAMS	#WC-71 "SAND DOLLAR"; SHEEN: REFER TO SPECIFICATIONS		
P11	SHERWIN WILLIAMS	#SW7011 "NATURAL CHOICE"; SHEEN: REFER TO SPECIFICATIONS		
P12	SHERWIN WILLIAMS	#SW6795 "MAJOR BLUE"; SHEEN: REFER TO SPECIFICATIONS		
PLASTIC LAMINATE				
PL-1				
PL-2				
TRIM				
WD1				

- GENERAL NOTES**
- A. REFER TO SHEET G001, CODE REVIEW, FOR REQUIRED FLAME SPREAD AND SMOKE DEVELOPMENT RATINGS OF ALL FINISHES. REFER TO FINISH SCHEDULE AND FINISH SPECIFICATIONS FOR ADDITIONAL INFORMATION.
- B. FLOOR FINISH PATTERNS ON PLAN ARE FOR GENERAL CONFIGURATION, INDICATING DIRECTION ONLY. U.N.O. UNLESS SPECIFICALLY INDICATED OTHERWISE ON PLAN, FLOORING SHALL BE INSTALLED CENTERED WITHIN THE ROOM OR SPACE WITH LONG DIRECTION OF THE FLOORING PLANK OR TILE RUNNING THE LONG DIRECTION OF THE ROOM OR SPACE.
- C. FULL FLOORING PLANKS, TILES, OR SHEETS SHALL BE USED IN FLOORING INSTALLATION WHEREVER POSSIBLE.
- D. ALL FLOOR FINISHES SHALL BE INSTALLED WITH TOP EDGES LEVEL W/ ADJACENT MATERIAL TOP EDGES. CONFIRM TILE THICKNESS AS THICKNESS MAY VARY; CONFIRM THAT NO OVERALL FLOATING OF FLOOR IS REQUIRED.
- E. REFER TO PLUMBING DRAWINGS FOR DIMENSIONS & LOCATIONS OF FLOOR DRAINS & FLOOR SINKS.
- F. REFER TO PARTITION TYPE DETAILS AND INTERIOR ELEVATIONS FOR HEIGHT OF WALL FINISHES.
- G. REFER TO INTERIOR ELEVATIONS FOR ADDITIONAL PAINT COLOR INFORMATION AND LOCATIONS.
- H. ALL FINISHES AND PAINT COLORS SHALL TERMINATE AT AN INSIDE CORNER WHEREVER POSSIBLE. U.N.O. GO SHALL REQUEST CLARIFICATION FROM ARCHITECT IF PRESCRIBED MATERIAL TERMINATION IS AMBIGUOUS OR INFEASIBLE.
- I. WALL TILE SHALL BE INSTALLED IN RESTROOMS TO A HEIGHT OF 5'-0" AFF. U.N.O. ON ALL PLUMBING WALLS, BEHIND PLUMBING FIXTURES - INCLUDING DRINKING FOUNTAINS - ON WALLS ADJACENT TO PLUMBING FIXTURES, AND BEHIND HAND DRYERS. ALL HOLLOW METAL DOOR FRAMES SHALL BE PAINTED.
- J. FRP IN KITCHENS SHALL BE FULL HEIGHT; FRP IN ALL OTHER APPLICATIONS SHALL BE TO 6'-0" U.N.O.
- K. WHERE APPLICABLE, PATCH & REPAIR FLOORING IN ALL SCOPE OF WORK AREAS TO MATCH EXISTING UNLESS NEW FINISH NOTED IN ROOM FINISH SCHEDULE.
- L. UPON COMPLETION OF THE WORK, THE G.C. SHALL PROVIDE AND LEAVE ON SITE (2) BOX EACH OF ALL WALL TILE, FLOOR TILE, CARPET TILE, AND CEILING TILE USED.

- FLOORING TRANSITION NOTES**
- A. ALL FLOORING TRANSITIONS SHALL COMPLY WITH ICC/ANSI A117.1: REFER TO ACCESSIBILITY GUIDELINES.
- B. COORDINATE FLOORING TRANSITIONS & BASE TILE INSTALLATION W/ MILLWORK SHOP DRAWINGS & FIELD CONDITIONS.
- C. TRANSITIONS BETWEEN ROOMS SHALL BE CENTERED ON DOOR FRAME.
- LVT to SC SCHLUTER VINPRO-U, COLOR TBD.
LVT to CVT SCHLUTER VINPRO-T, COLOR TBD.
LVT to CPT SCHLUTER VINPRO-S, COLOR TBD.
LVT to TILE SCHLUTER RENO-U, COLOR TBD.

DRAWING NOTES

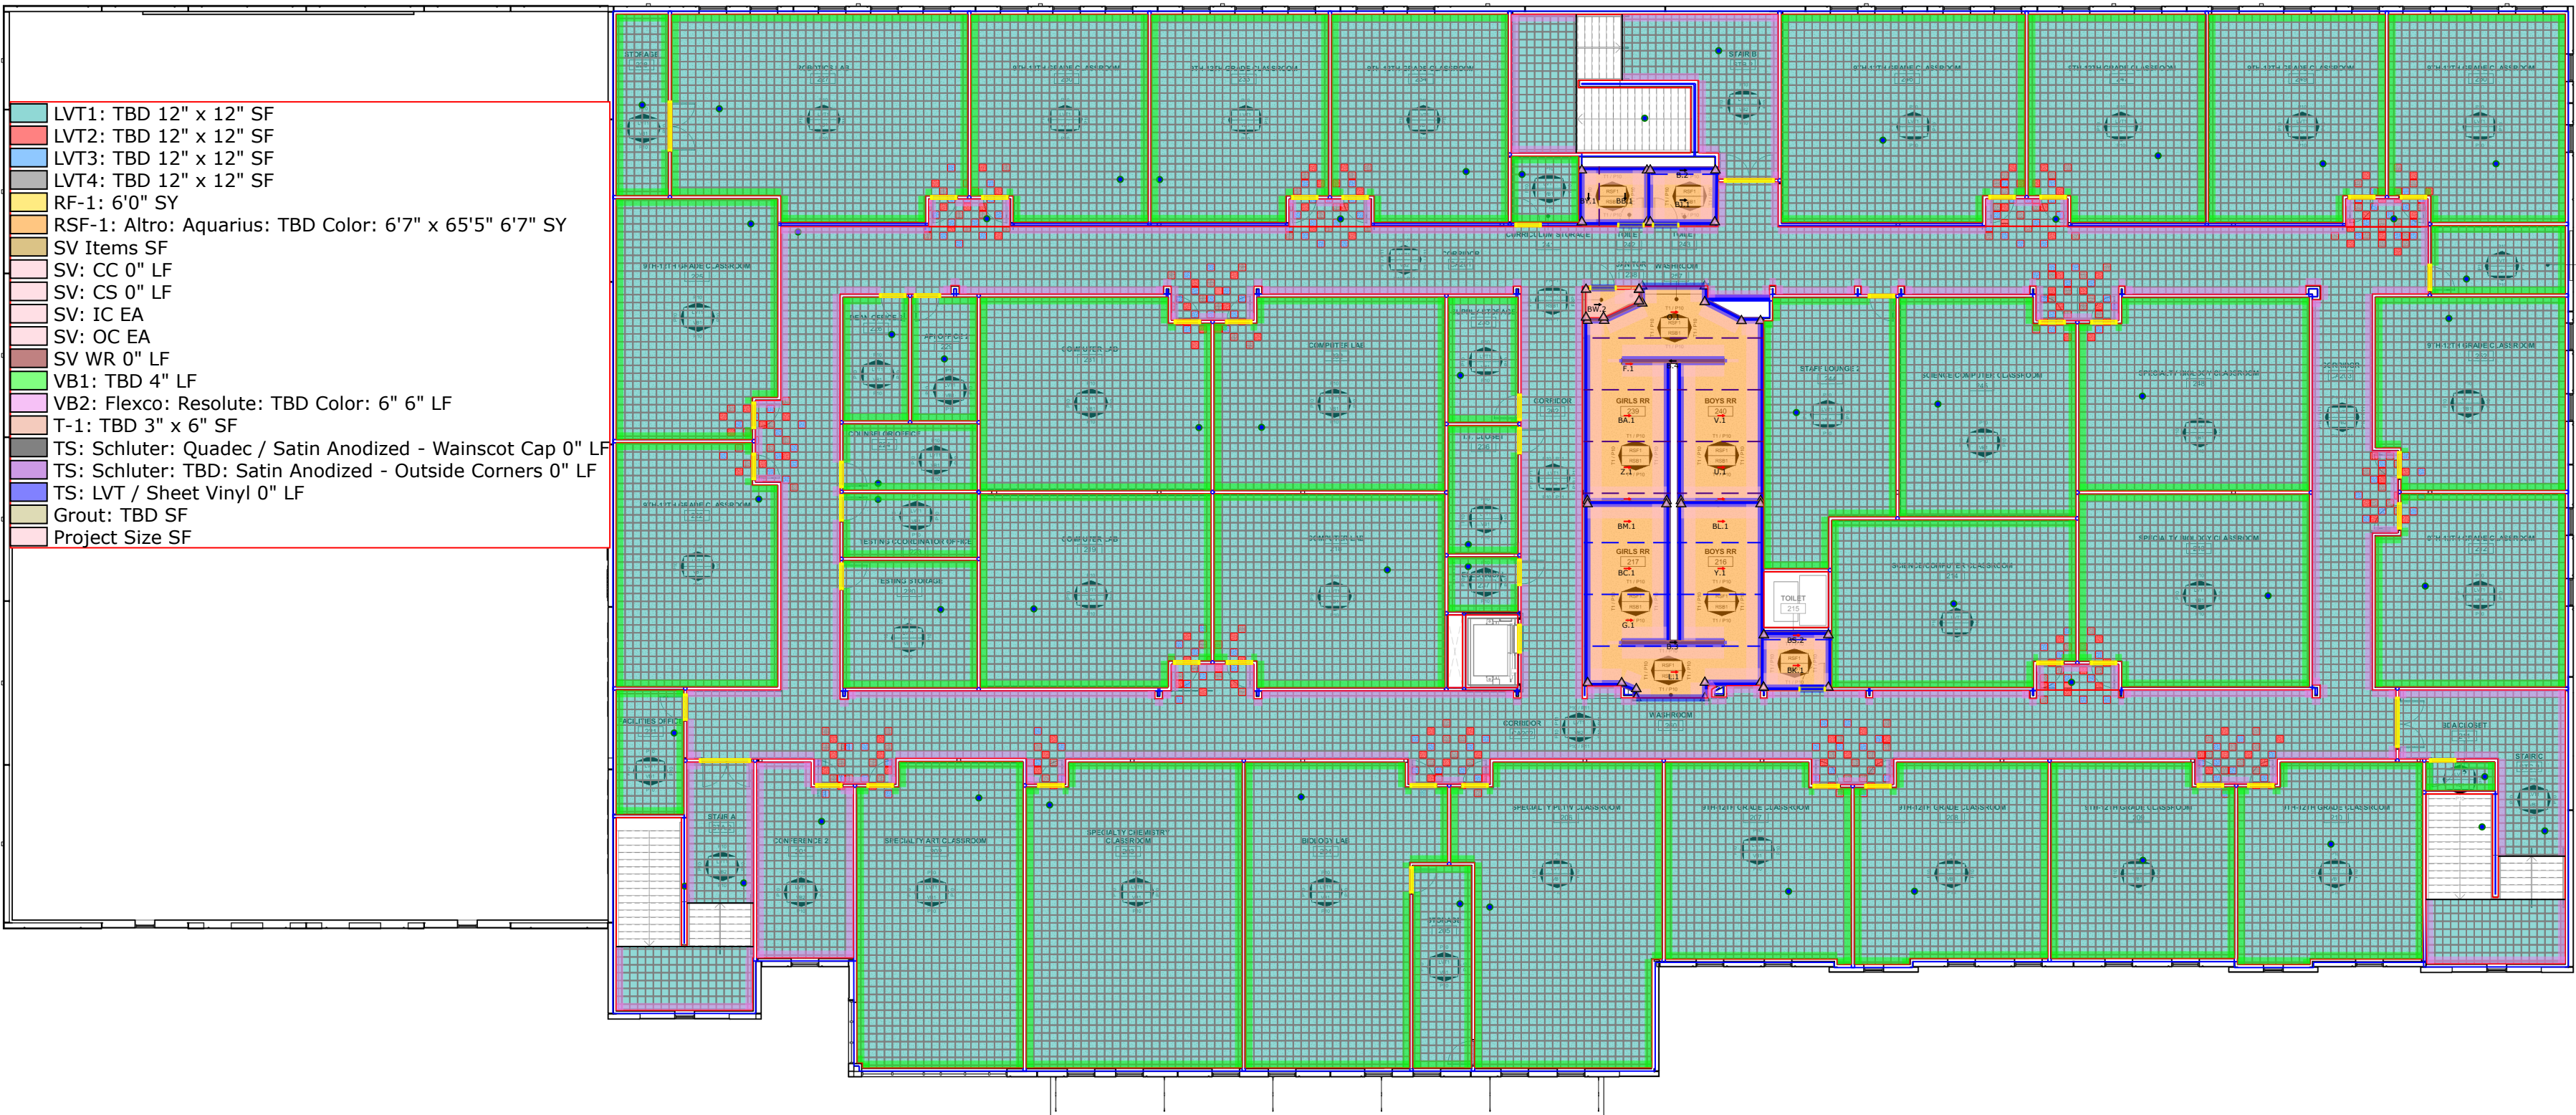

SECOND FLOOR FINISH PLAN
1" = 10'-0"

MUSSMAN ARCHITECTS
610 N. MAIN STREET | GREENVILLE, SC 29601
604.626.6300
musmanarchitects.com

STATE OF FLORIDA
JACOB W. MUSMAN
REGISTERED ARCHITECT
ARCH. NO. 133990
SEAL DATE: 07.20.2020

SUMMIT

SEMINOLE SCIENCE ACADEMY
3580 N 17-92
LAKE MARY, FL 32746

SEMINOLE SCIENCE ACADEMY
11.05.2024
NO. 11.05.2024
DATE 11.05.2024
DESCRIPTION 01/10/2024
ISSUE FOR PERMIT

PROJECT NUMBER: 024007
FINISH PLAN
A1102
SHEET NO.